


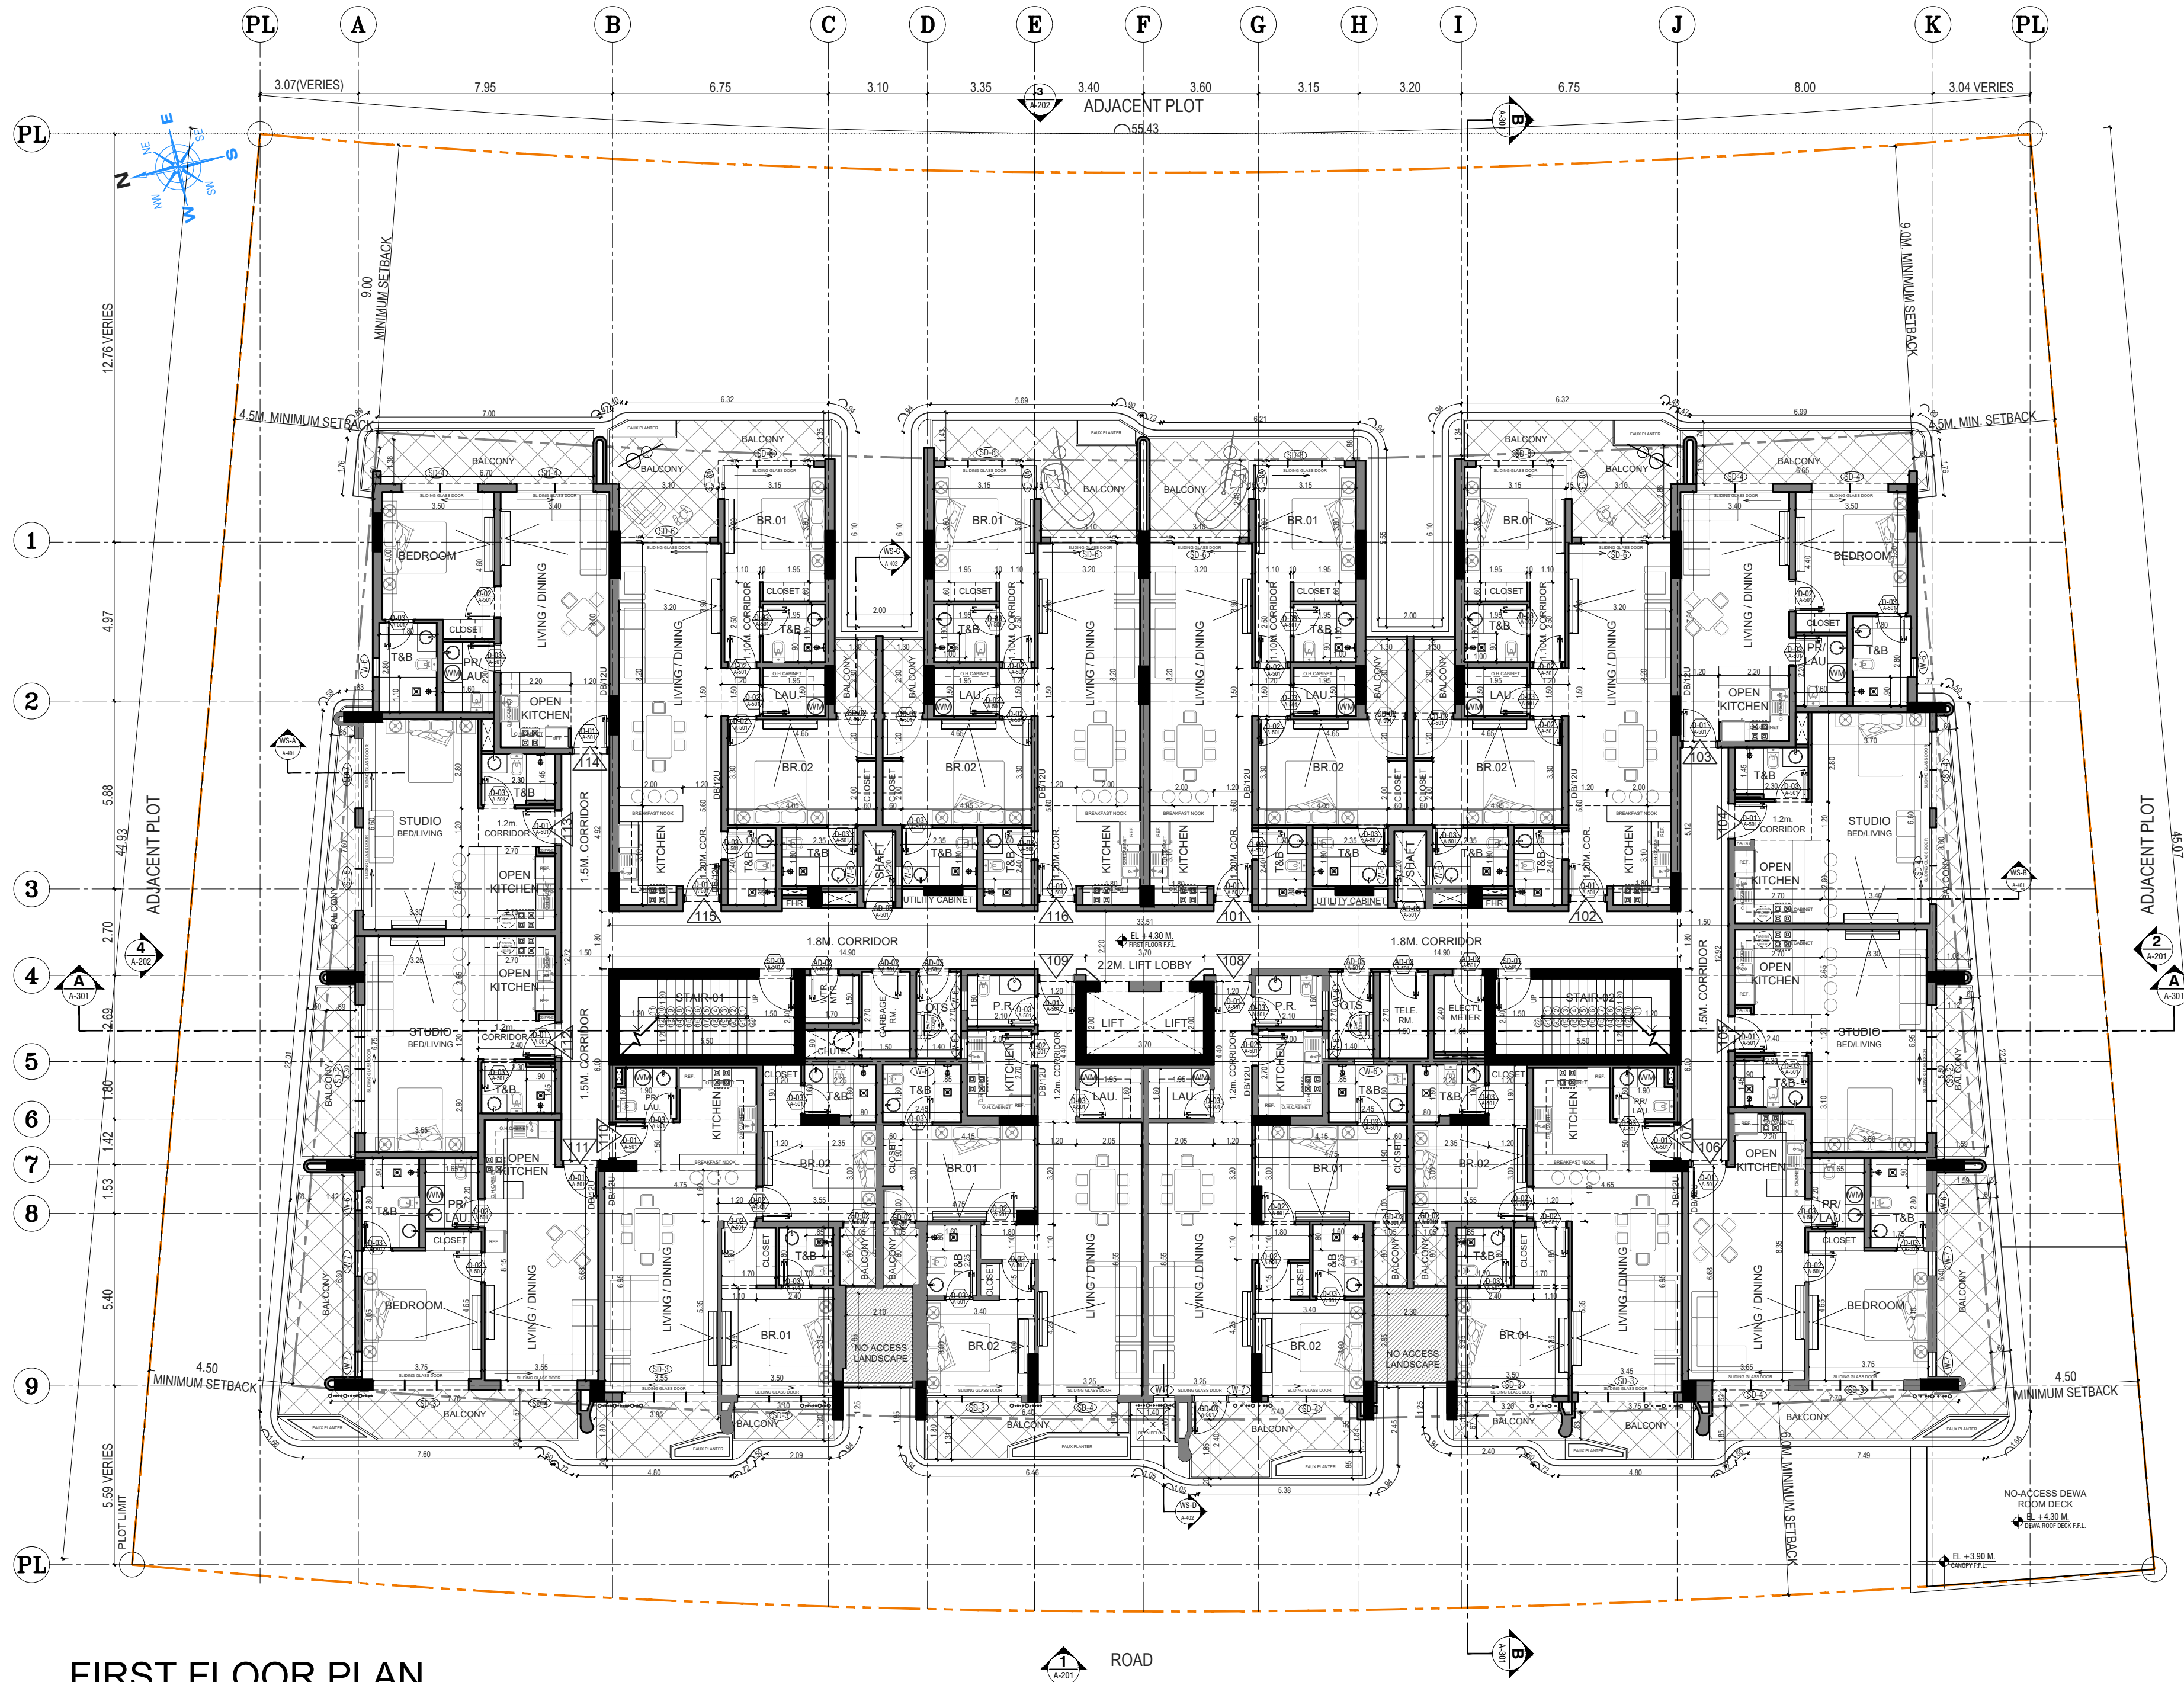



- NOTE:
1. THIS DRAWING IS THE PROPERTY OF MAPLE ENGINEERING CONSULTANTS, P.O. BOX. 214389, DUBAI, U.A.E. IT IS NOT ALLOWED TO REPRODUCE ITS CONTENTS IN ANY FORM EXCEPT FOR THE PURPOSE FOR WHICH IT IS INTENDED.
 2. THIS DRAWING IS NOT TO BE SCALED. STATED DIMENSIONS ONLY ARE TO BE CONSIDERED.
 3. ANY DISCREPANCIES ARE TO BE BROUGHT TO THE ATTENTION OF THE ENGINEER AND RESOLVED BEFORE COMMENCEMENT OF ANY WORK.
 4. FOR CONSTRUCTION S.I. UNIT TO BE FOLLOWED.
 5. THIS DRAWINGS MUST NOT BE USED AS SHOP DRAWINGS / FOR CONSTRUCTION DRAWING. MAIN CONTRACTOR TO PREPARE SHOP DRAWING BASED PROJECT NEEDS, LATEST AUTHORITIES RULES AND REGULATIONS AND PROJECT ACTUAL CONDITION FOR MAPLE AND OWNER'S APPROVAL.
 6. IT IS MAIN CONTRACTOR'S RESPONSIBILITY TO MAKE SHOP DRAWINGS AND FULL COORDINATION WITH ALL SUB-CONTRACTORS IN ORDER TO PREPARE SHOP DRAWINGS.



ARCH. CIVIL. ELEC. TEL. HVAC FIRE F. PLUM. ETC.

REV. NO. DATE DESCRIPTION

CONSULTANT:
MAPLE ENGINEERING CONSULTANTS
TEL: 04-3360663 | FAX: 04-3360667 | P.O. BOX: 214389
WWW.THEMAPLE.AE | EMAIL: INFO@THEMAPLE.AE

CLIENT:
ELTAHIR ELTAYEB YOUNIS

PLOT No.: RG-30 LOCATION: DUBAI AVIATION CITY, DUBAI


PROJECT: P - 345- 2024

PROPOSED G+4+R RESIDENTIAL BUILDING

DRAWING TITLE:

FIRST FLOOR PLAN

DESIGNED BY: MAPLE ENGINEERING CONSULTANTS
ARCHITECT: AR. MARK DESON ABAYON 309120915
ARCHITECT: AR. ELMER ALEA DIAO 113098
STRUCTURAL: ENGR. ASMA AMIRI SHAMLOO 109930
DATE: SEPTEMBER 2, 2025
SCALE: N.T.S. PAPER SIZE: A2
SHEET NO.: A-102 REVISION: 0

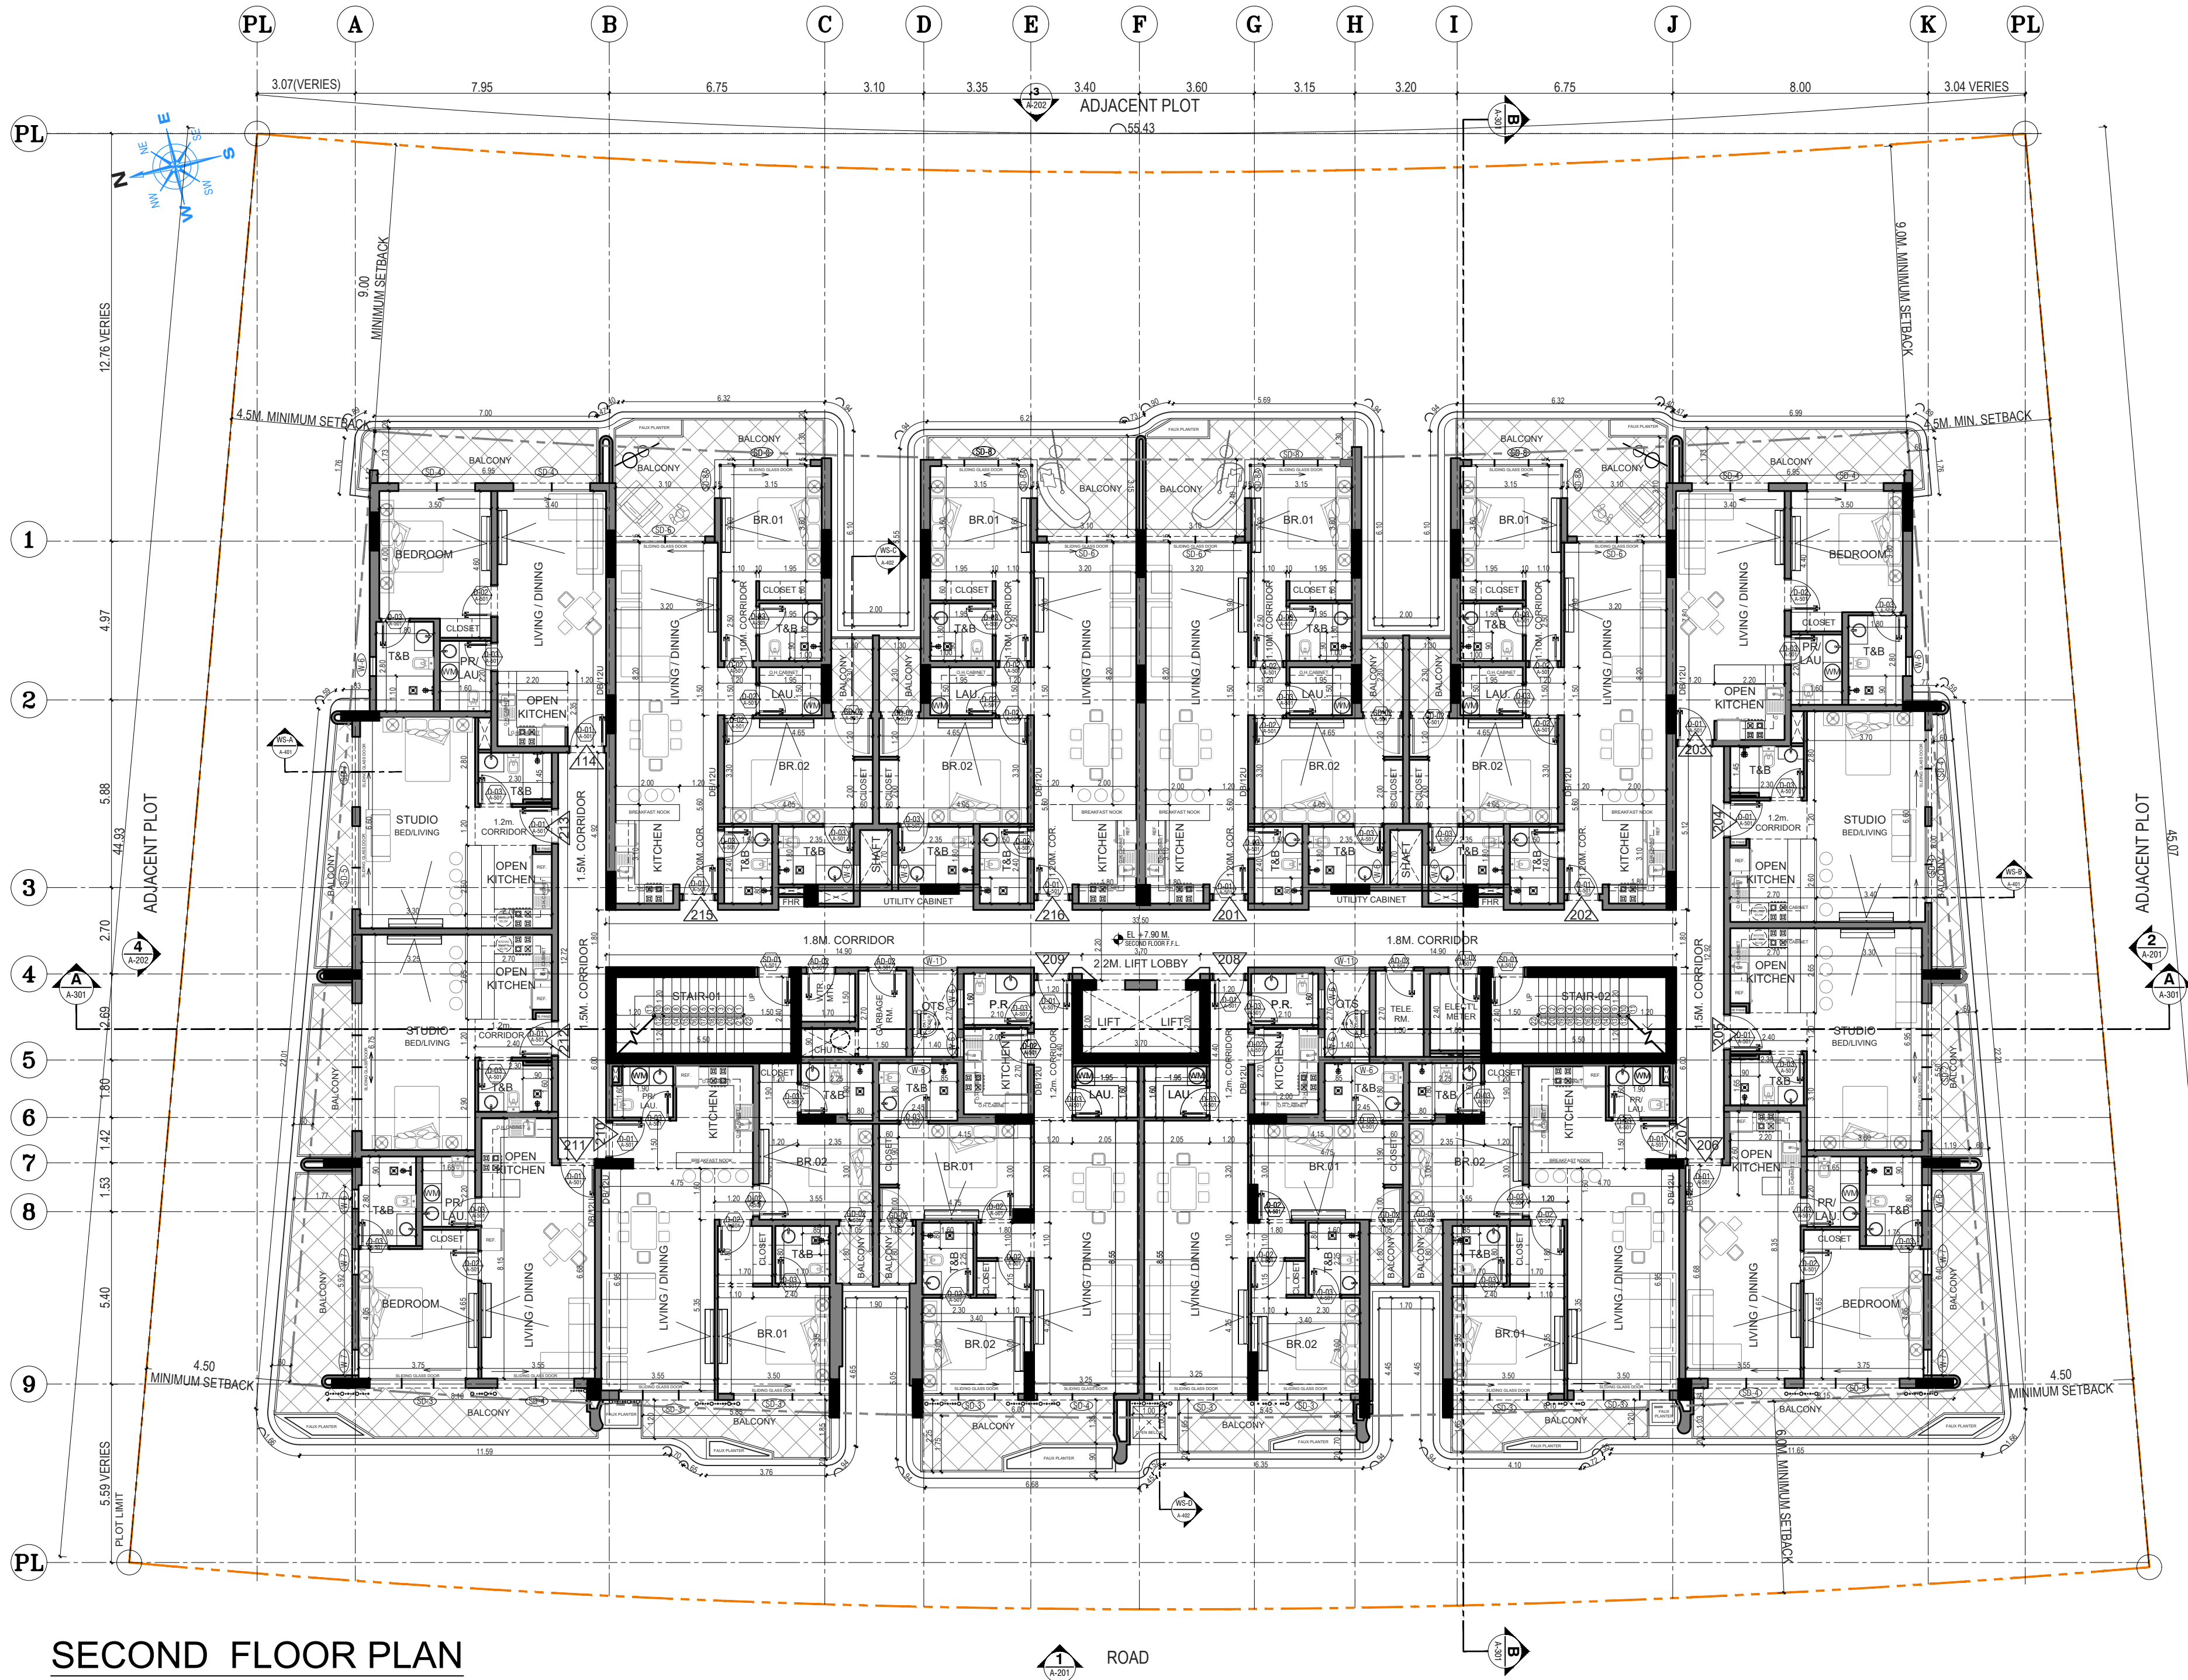

SECOND FLOOR PLAN

- NOTE:
1. THIS DRAWING IS THE PROPERTY OF MAPLE ENGINEERING CONSULTANTS, P.O. BOX. 214389, DUBAI, U.A.E. IT IS NOT ALLOWED TO REPRODUCE ITS CONTENTS IN ANY FORM EXCEPT FOR THE PURPOSE FOR WHICH IT IS INTENDED.
 2. THIS DRAWING IS NOT TO BE SCALED. STATED DIMENSIONS ONLY ARE TO BE CONSIDERED.
 3. ANY DISCREPANCIES ARE TO BE BROUGHT TO THE ATTENTION OF THE ENGINEER AND RESOLVED BEFORE COMMENCEMENT OF ANY WORK.
 4. FOR CONSTRUCTION S.I. UNIT TO BE FOLLOWED.
 5. THIS DRAWINGS MUST NOT BE USED AS SHOP DRAWINGS / FOR CONSTRUCTION DRAWING. MAIN CONTRACTOR TO PREPARE SHOP DRAWING BASED PROJECT NEEDS, LATEST AUTHORITIES RULES AND REGULATIONS AND PROJECT ACTUAL CONDITION FOR MAPLE AND OWNER'S APPROVAL.
 6. IT IS MAIN CONTRACTOR'S RESPONSIBILITY TO MAKE SHOP DRAWINGS AND FULL COORDINATION WITH ALL SUB-CONTRACTORS IN ORDER TO PREPARE SHOP DRAWINGS.



ARCH. CIVIL. ELEC. TEL. HVAC FIRE F. PLUM. ETC.

REV. NO. DATE DESCRIPTION

CONSULTANT:
MAPLE ENGINEERING CONSULTANTS
TEL: 04-3360663 | FAX: 04-3360667 | P.O. BOX: 214389
WWW.THEMAPLE.AE | EMAIL: INFO@THEMAPLE.AE

CLIENT:
ELTAHIR ELTAYEB YOUNIS

PLOT No.: RG-30 LOCATION: DUBAI AVIATION CITY, DUBAI


PROJECT: P - 345- 2024

PROPOSED G+4+R RESIDENTIAL BUILDING

DRAWING TITLE:

SECOND FLOOR PLAN

DESIGNED BY: MAPLE ENGINEERING CONSULTANTS
ARCHITECT: AR. MARK DESON ABAYON 309120915
ARCHITECT: AR. ELMER ALEA DIAO 113098
STRUCTURAL: ENGR. ASMA AMIRI SHAMLOO 109930
DATE: SEPTEMBER 2, 2025
SCALE: N.T.S. PAPER SIZE: A2
SHEET NO.: A-103 REVISION: 0

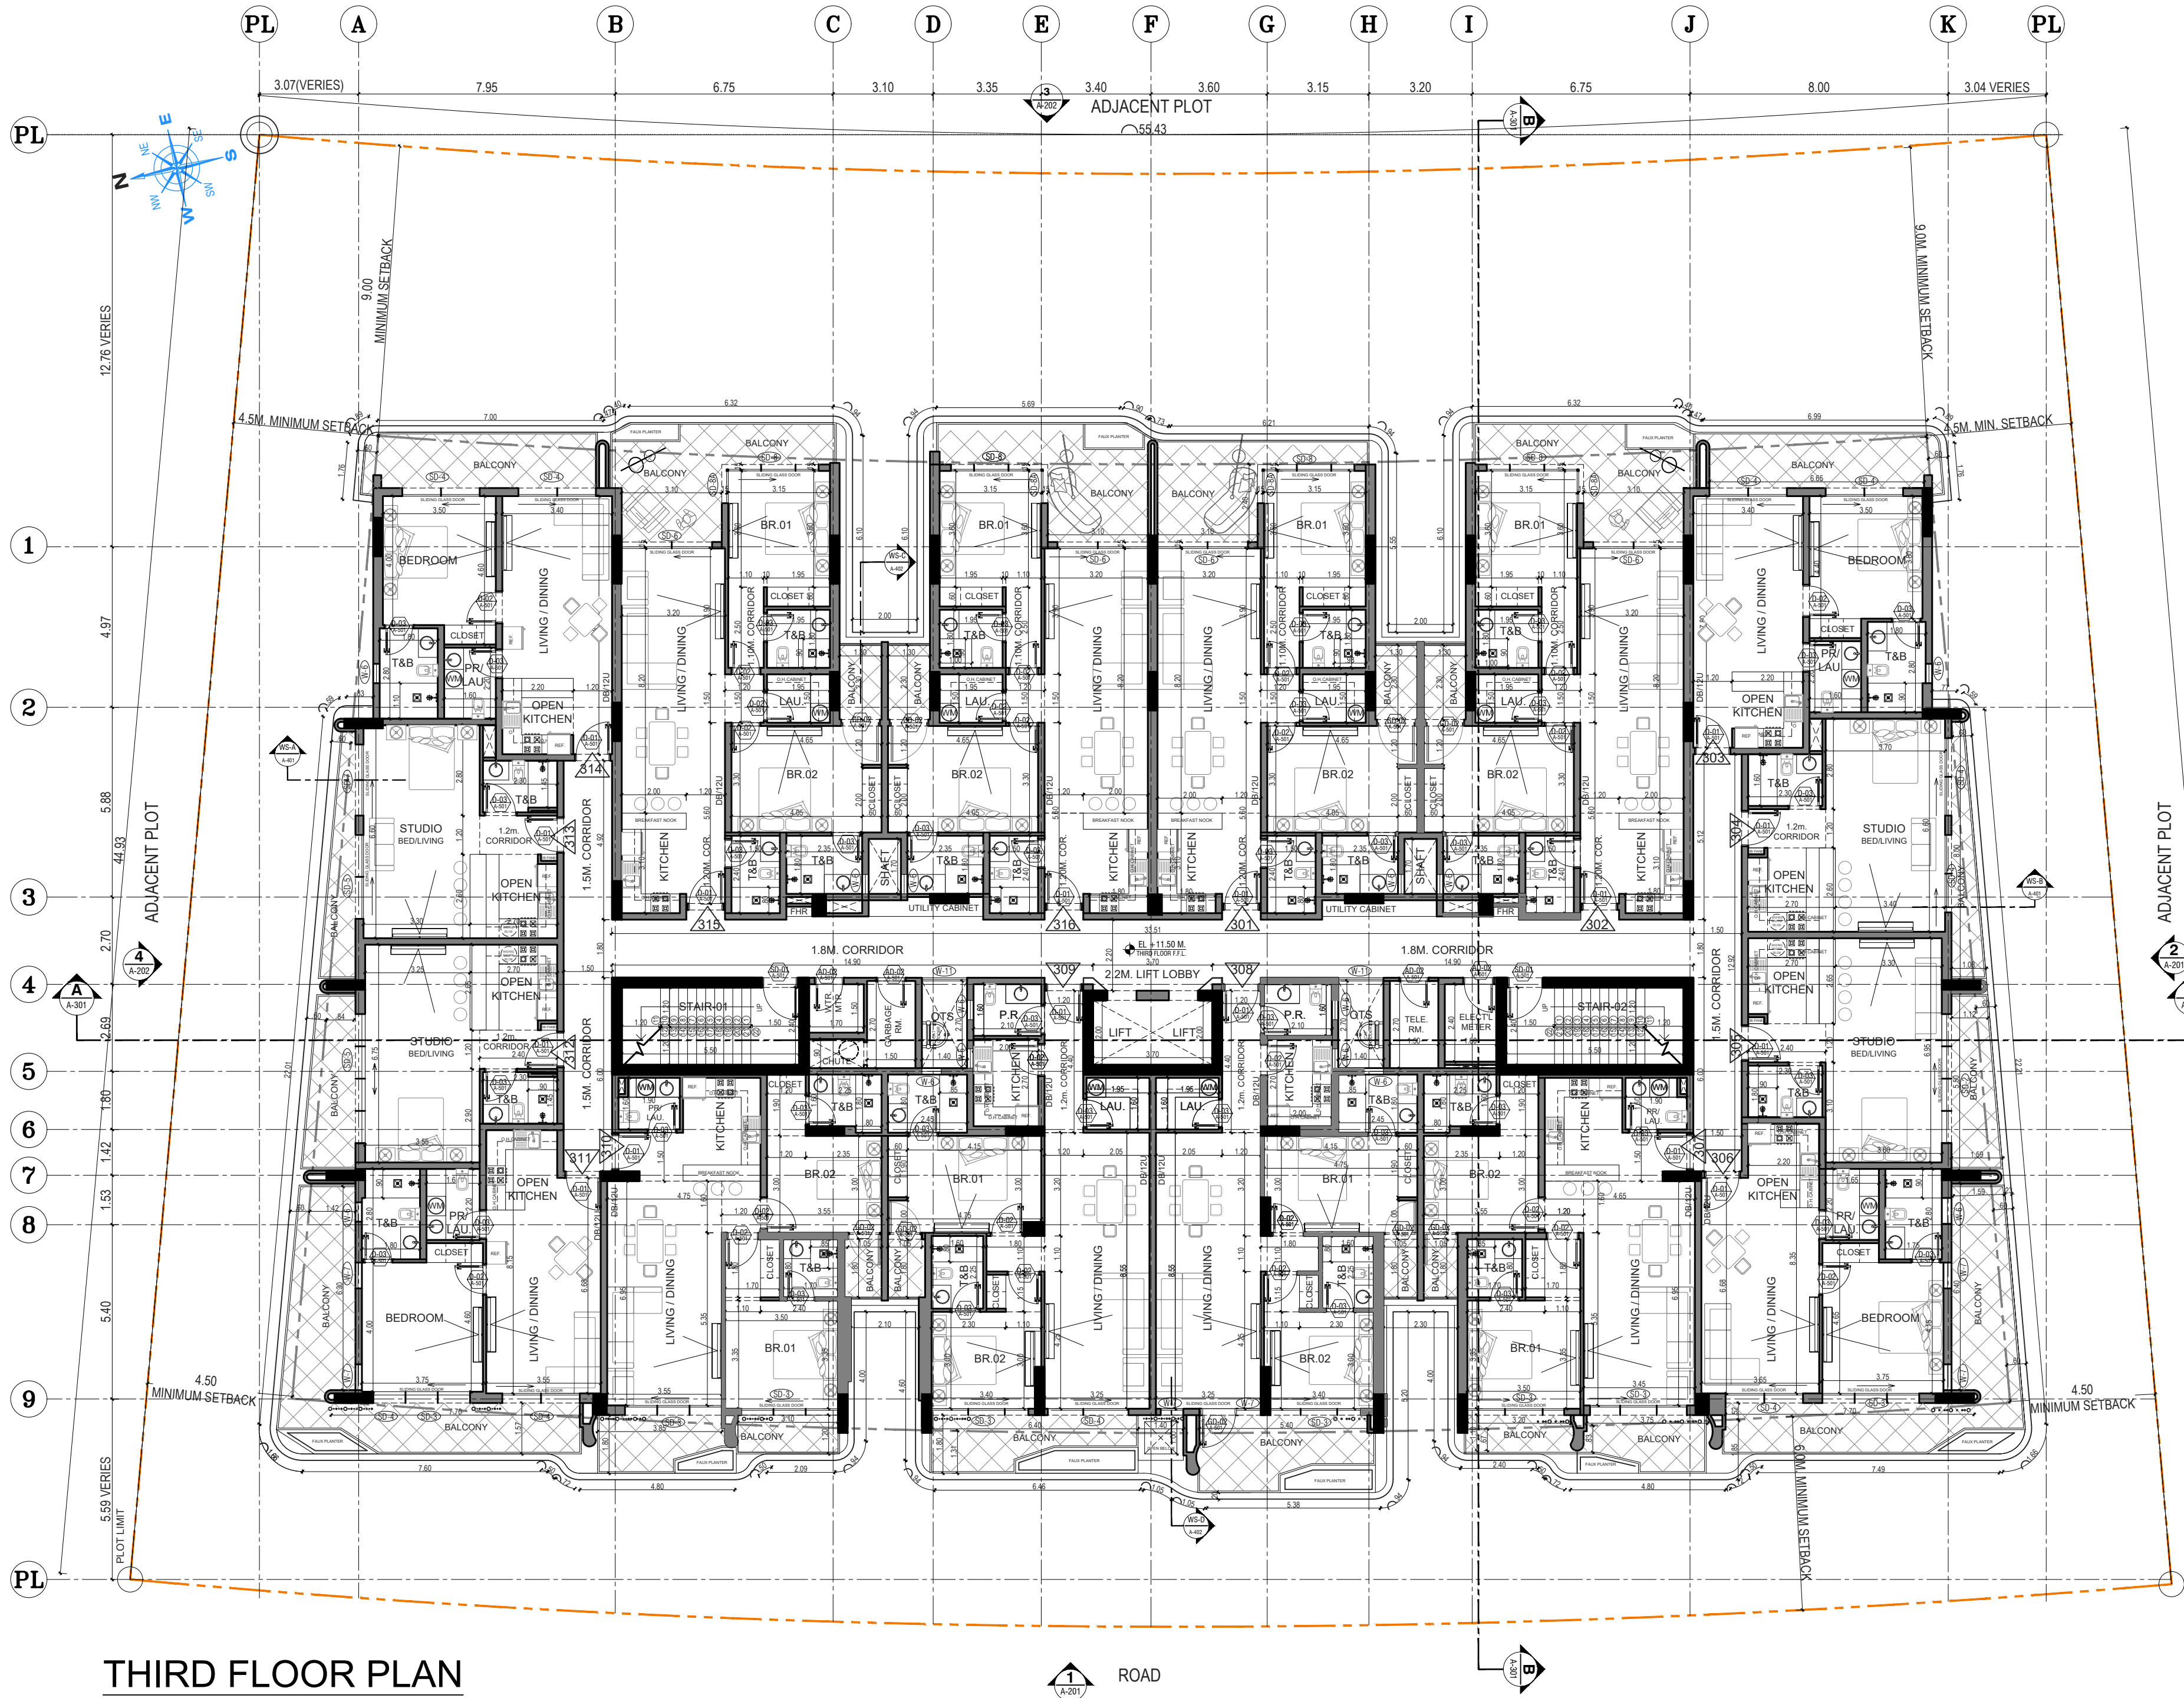

- NOTE:
1. THIS DRAWING IS THE PROPERTY OF MAPLE ENGINEERING CONSULTANTS, P.O. BOX. 214389, DUBAI, U.A.E. IT IS NOT ALLOWED TO REPRODUCE ITS CONTENTS IN ANY FORM EXCEPT FOR THE PURPOSE FOR WHICH IT IS INTENDED.
 2. THIS DRAWING IS NOT TO BE SCALED. STATED DIMENSIONS ONLY ARE TO BE CONSIDERED.
 3. ANY DISCREPANCIES ARE TO BE BROUGHT TO THE ATTENTION OF THE ENGINEER AND RESOLVED BEFORE COMMENCEMENT OF ANY WORK.
 4. FOR CONSTRUCTION S.I. UNIT TO BE FOLLOWED.
 5. THIS DRAWINGS MUST NOT BE USED AS SHOP DRAWINGS / FOR CONSTRUCTION DRAWING. MAIN CONTRACTOR TO PREPARE SHOP DRAWING BASED PROJECT NEEDS, LATEST AUTHORITIES RULES AND REGULATIONS AND PROJECT ACTUAL CONDITION FOR MAPLE AND OWNER'S APPROVAL.
 6. IT IS MAIN CONTRACTOR'S RESPONSIBILITY TO MAKE SHOP DRAWINGS AND FULL COORDINATION WITH ALL SUB-CONTRACTORS IN ORDER TO PREPARE SHOP DRAWINGS.



ARCH. CIVIL. ELEC. TEL. HVAC FIRE F. PLUM. ETC.

REV. NO. DATE DESCRIPTION

CONSULTANT:
MAPLE ENGINEERING CONSULTANTS
TEL: 04-3360663 | FAX: 04-3360667 | P.O. BOX: 214389
WWW.THEMAPLE.AE | EMAIL: INFO@THEMAPLE.AE

CLIENT:
ELTAHIR ELTAYEB YOUNIS

PLOT No.: RG-30 LOCATION: DUBAI AVIATION CITY, DUBAI


PROJECT: P - 345- 2024

PROPOSED G+4+R RESIDENTIAL BUILDING

DRAWING TITLE:

THIRD FLOOR PLAN

DESIGNED BY: MAPLE ENGINEERING CONSULTANTS
ARCHITECT: AR. MARK DESON ABAYON 309120915
ARCHITECT: AR. ELMER ALEA DIAO 113098
STRUCTURAL: ENGR. ASMA AMIRI SHAMLOO 109930
DATE: SEPTEMBER 2, 2025
SCALE: N.T.S. PAPER SIZE: A2
SHEET NO.: A-104 REVISION: 0

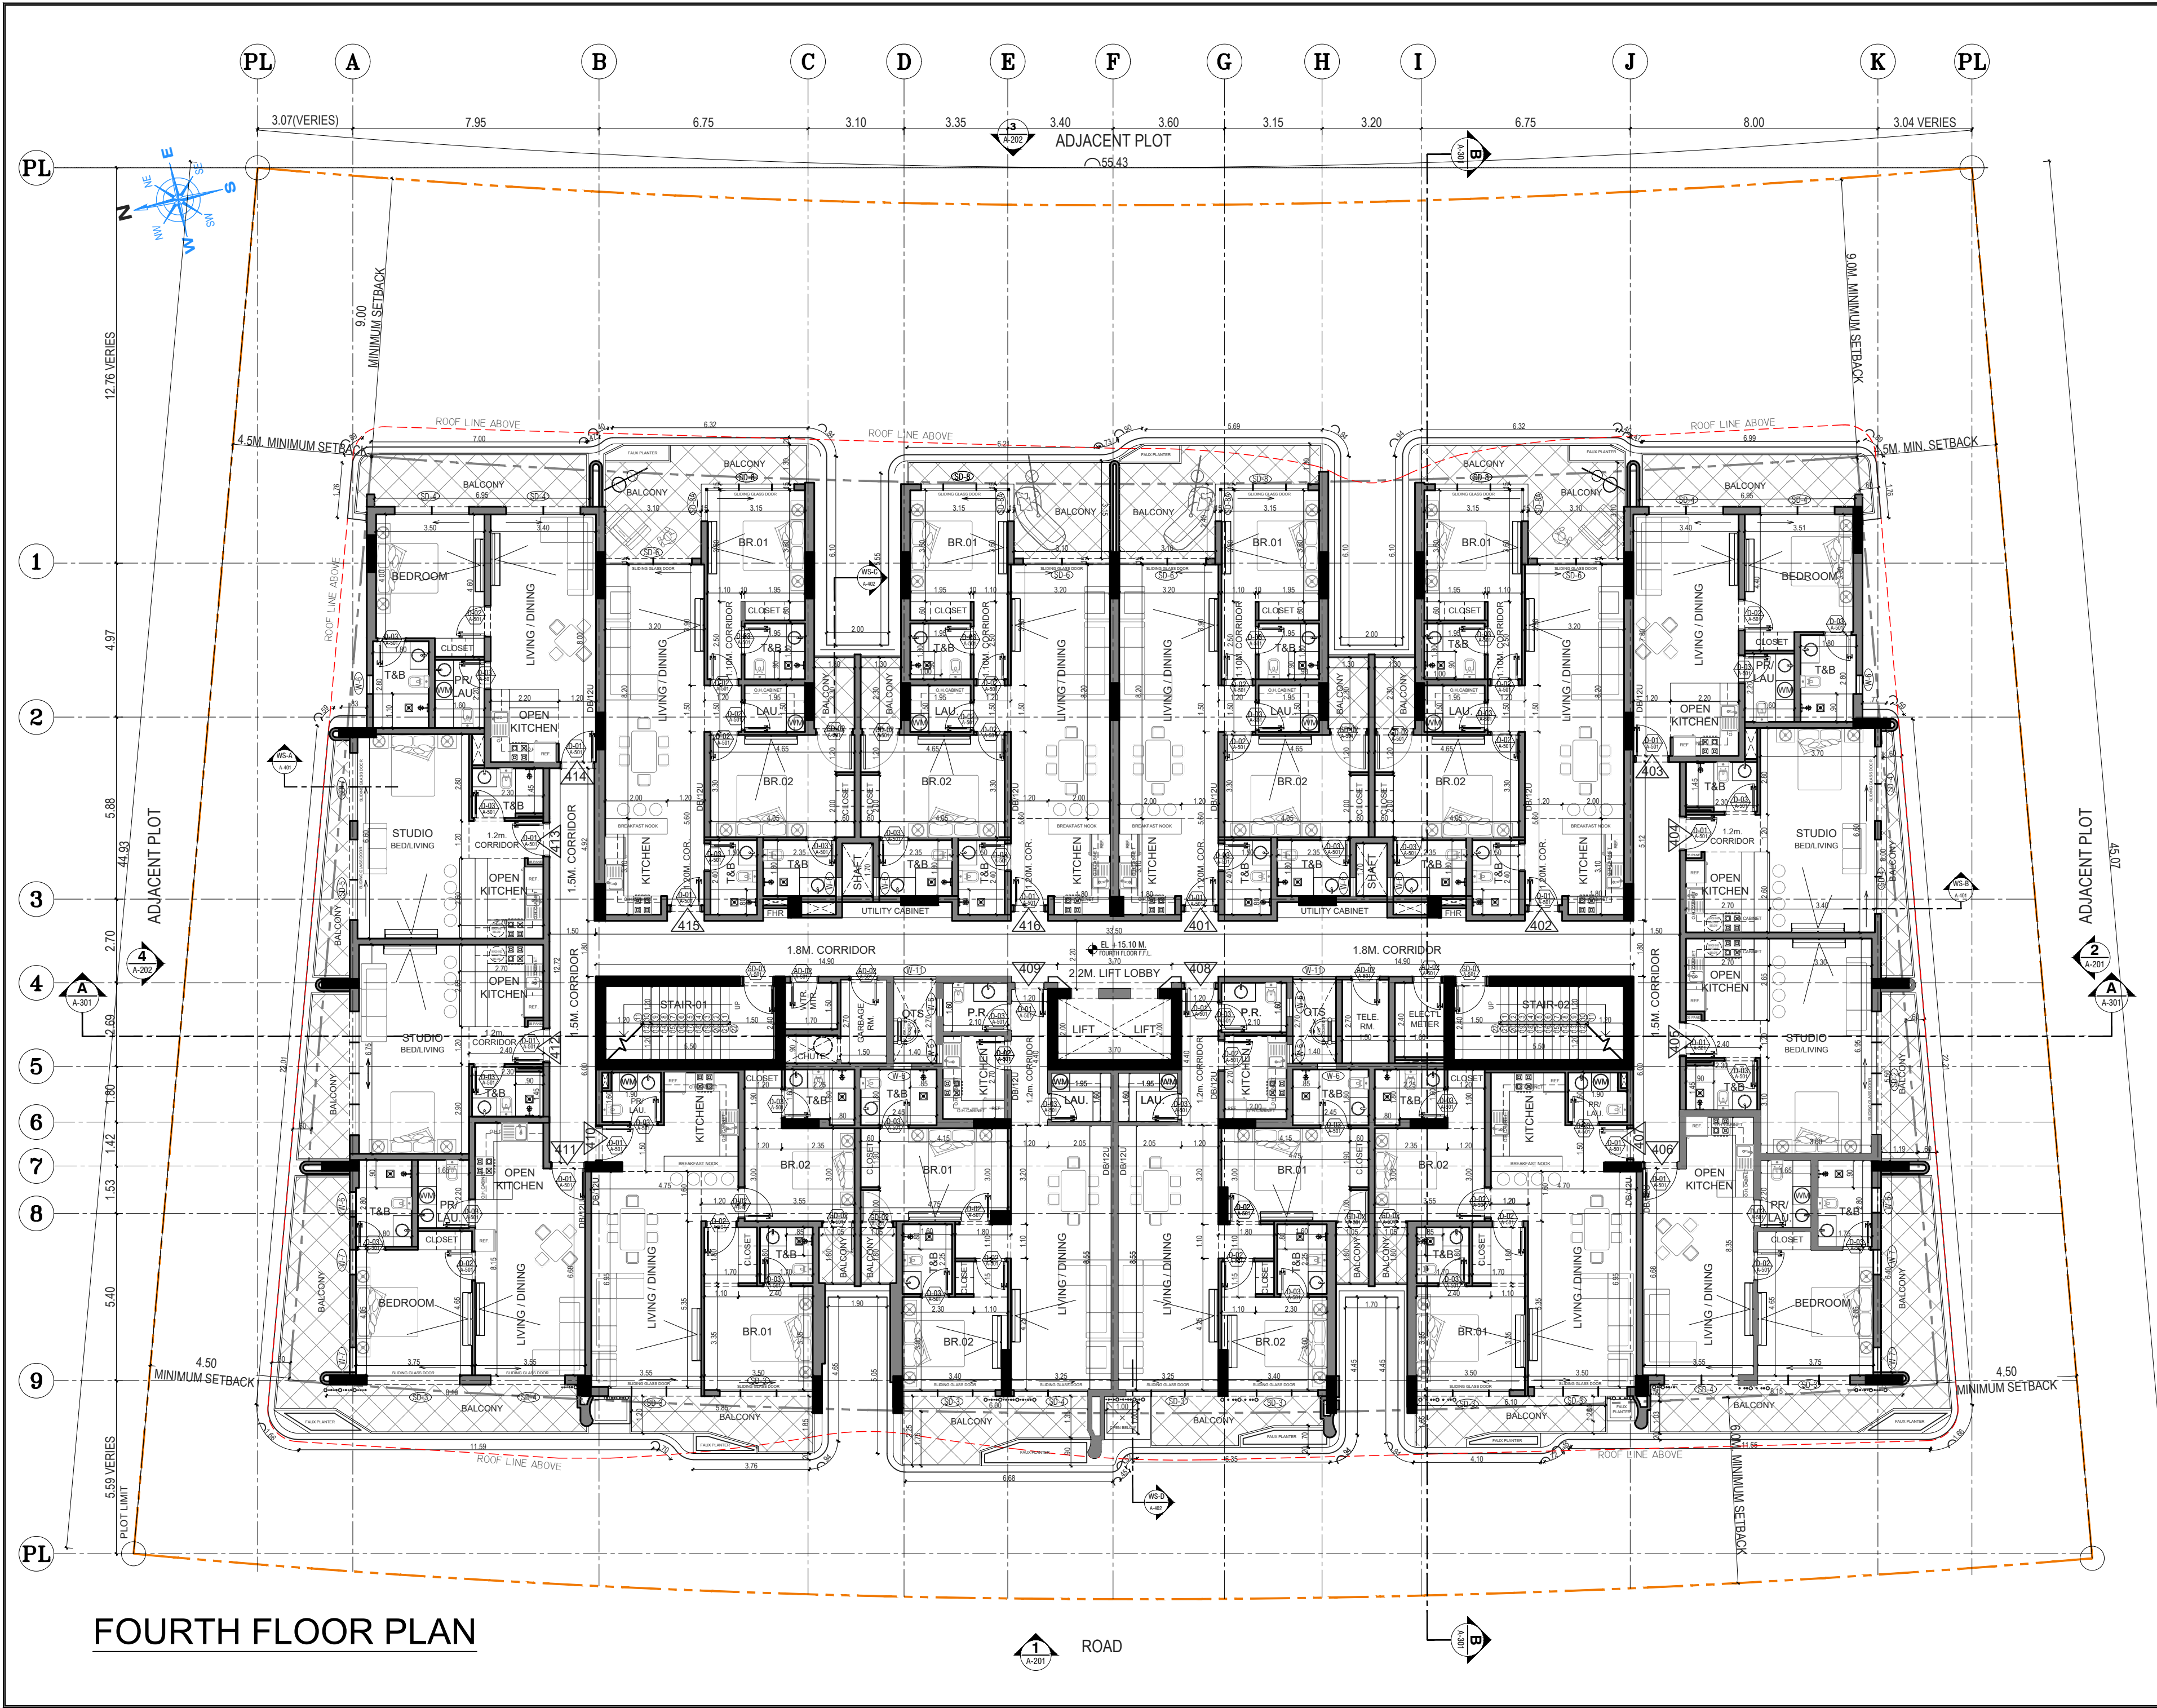

- NOTE:
1. THIS DRAWING IS THE PROPERTY OF MAPLE ENGINEERING CONSULTANTS, P.O. BOX. 214389, DUBAI, U.A.E. IT IS NOT ALLOWED TO REPRODUCE ITS CONTENTS IN ANY FORM EXCEPT FOR THE PURPOSE FOR WHICH IT IS INTENDED.
 2. THIS DRAWING IS NOT TO BE SCALED. STATED DIMENSIONS ONLY ARE TO BE CONSIDERED.
 3. ANY DISCREPANCIES ARE TO BE BROUGHT TO THE ATTENTION OF THE ENGINEER AND RESOLVED BEFORE COMMENCEMENT OF ANY WORK.
 4. FOR CONSTRUCTION S.I. UNIT TO BE FOLLOWED.
 5. THIS DRAWINGS MUST NOT TO BE USED AS SHOP DRAWINGS / FOR CONSTRUCTION DRAWING. MAIN CONTRACTOR TO PREPARE SHOP DRAWING BASED PROJECT NEEDS, LATEST AUTHORITIES RULES AND REGULATIONS AND PROJECT ACTUAL CONDITION FOR MAPLE AND OWNER'S APPROVAL.
 6. IT IS MAIN CONTRACTOR'S RESPONSIBILITY TO MAKE SHOP DRAWINGS AND FULL COORDINATION WITH ALL SUB-CONTRACTORS IN ORDER TO PREPARE SHOP DRAWINGS.



ARCH. CIVIL. ELEC. TEL. HVAC FIRE F. PLUM. ETC.

REV. NO. DATE DESCRIPTION

CONSULTANT:
MAPLE ENGINEERING CONSULTANTS
TEL: 04-3360663 | FAX: 04-3360667 | P.O. BOX: 214389
WWW.THEMAPLE.AE | EMAIL: INFO@THEMAPLE.AE

CLIENT:
ELTAHIR ELTAYEB YOUNIS

PLOT No.: RG-30 LOCATION: DUBAI AVIATION CITY, DUBAI


PROJECT: P - 345- 2024

PROPOSED G+4+R RESIDENTIAL BUILDING

DRAWING TITLE:

FOURTH FLOOR PLAN

DESIGNED BY: MAPLE ENGINEERING CONSULTANTS
ARCHITECT: AR. MARK DESON ABAYON 309120915
ARCHITECT: AR. ELMER ALEA DIAO 113098
STRUCTURAL: ENGR. ASMA AMIRI SHAMLOO 109930
DATE: SEPTEMBER 2, 2025
SCALE: N.T.S. PAPER SIZE: A2
SHEET NO.: A-105 REVISION: 0

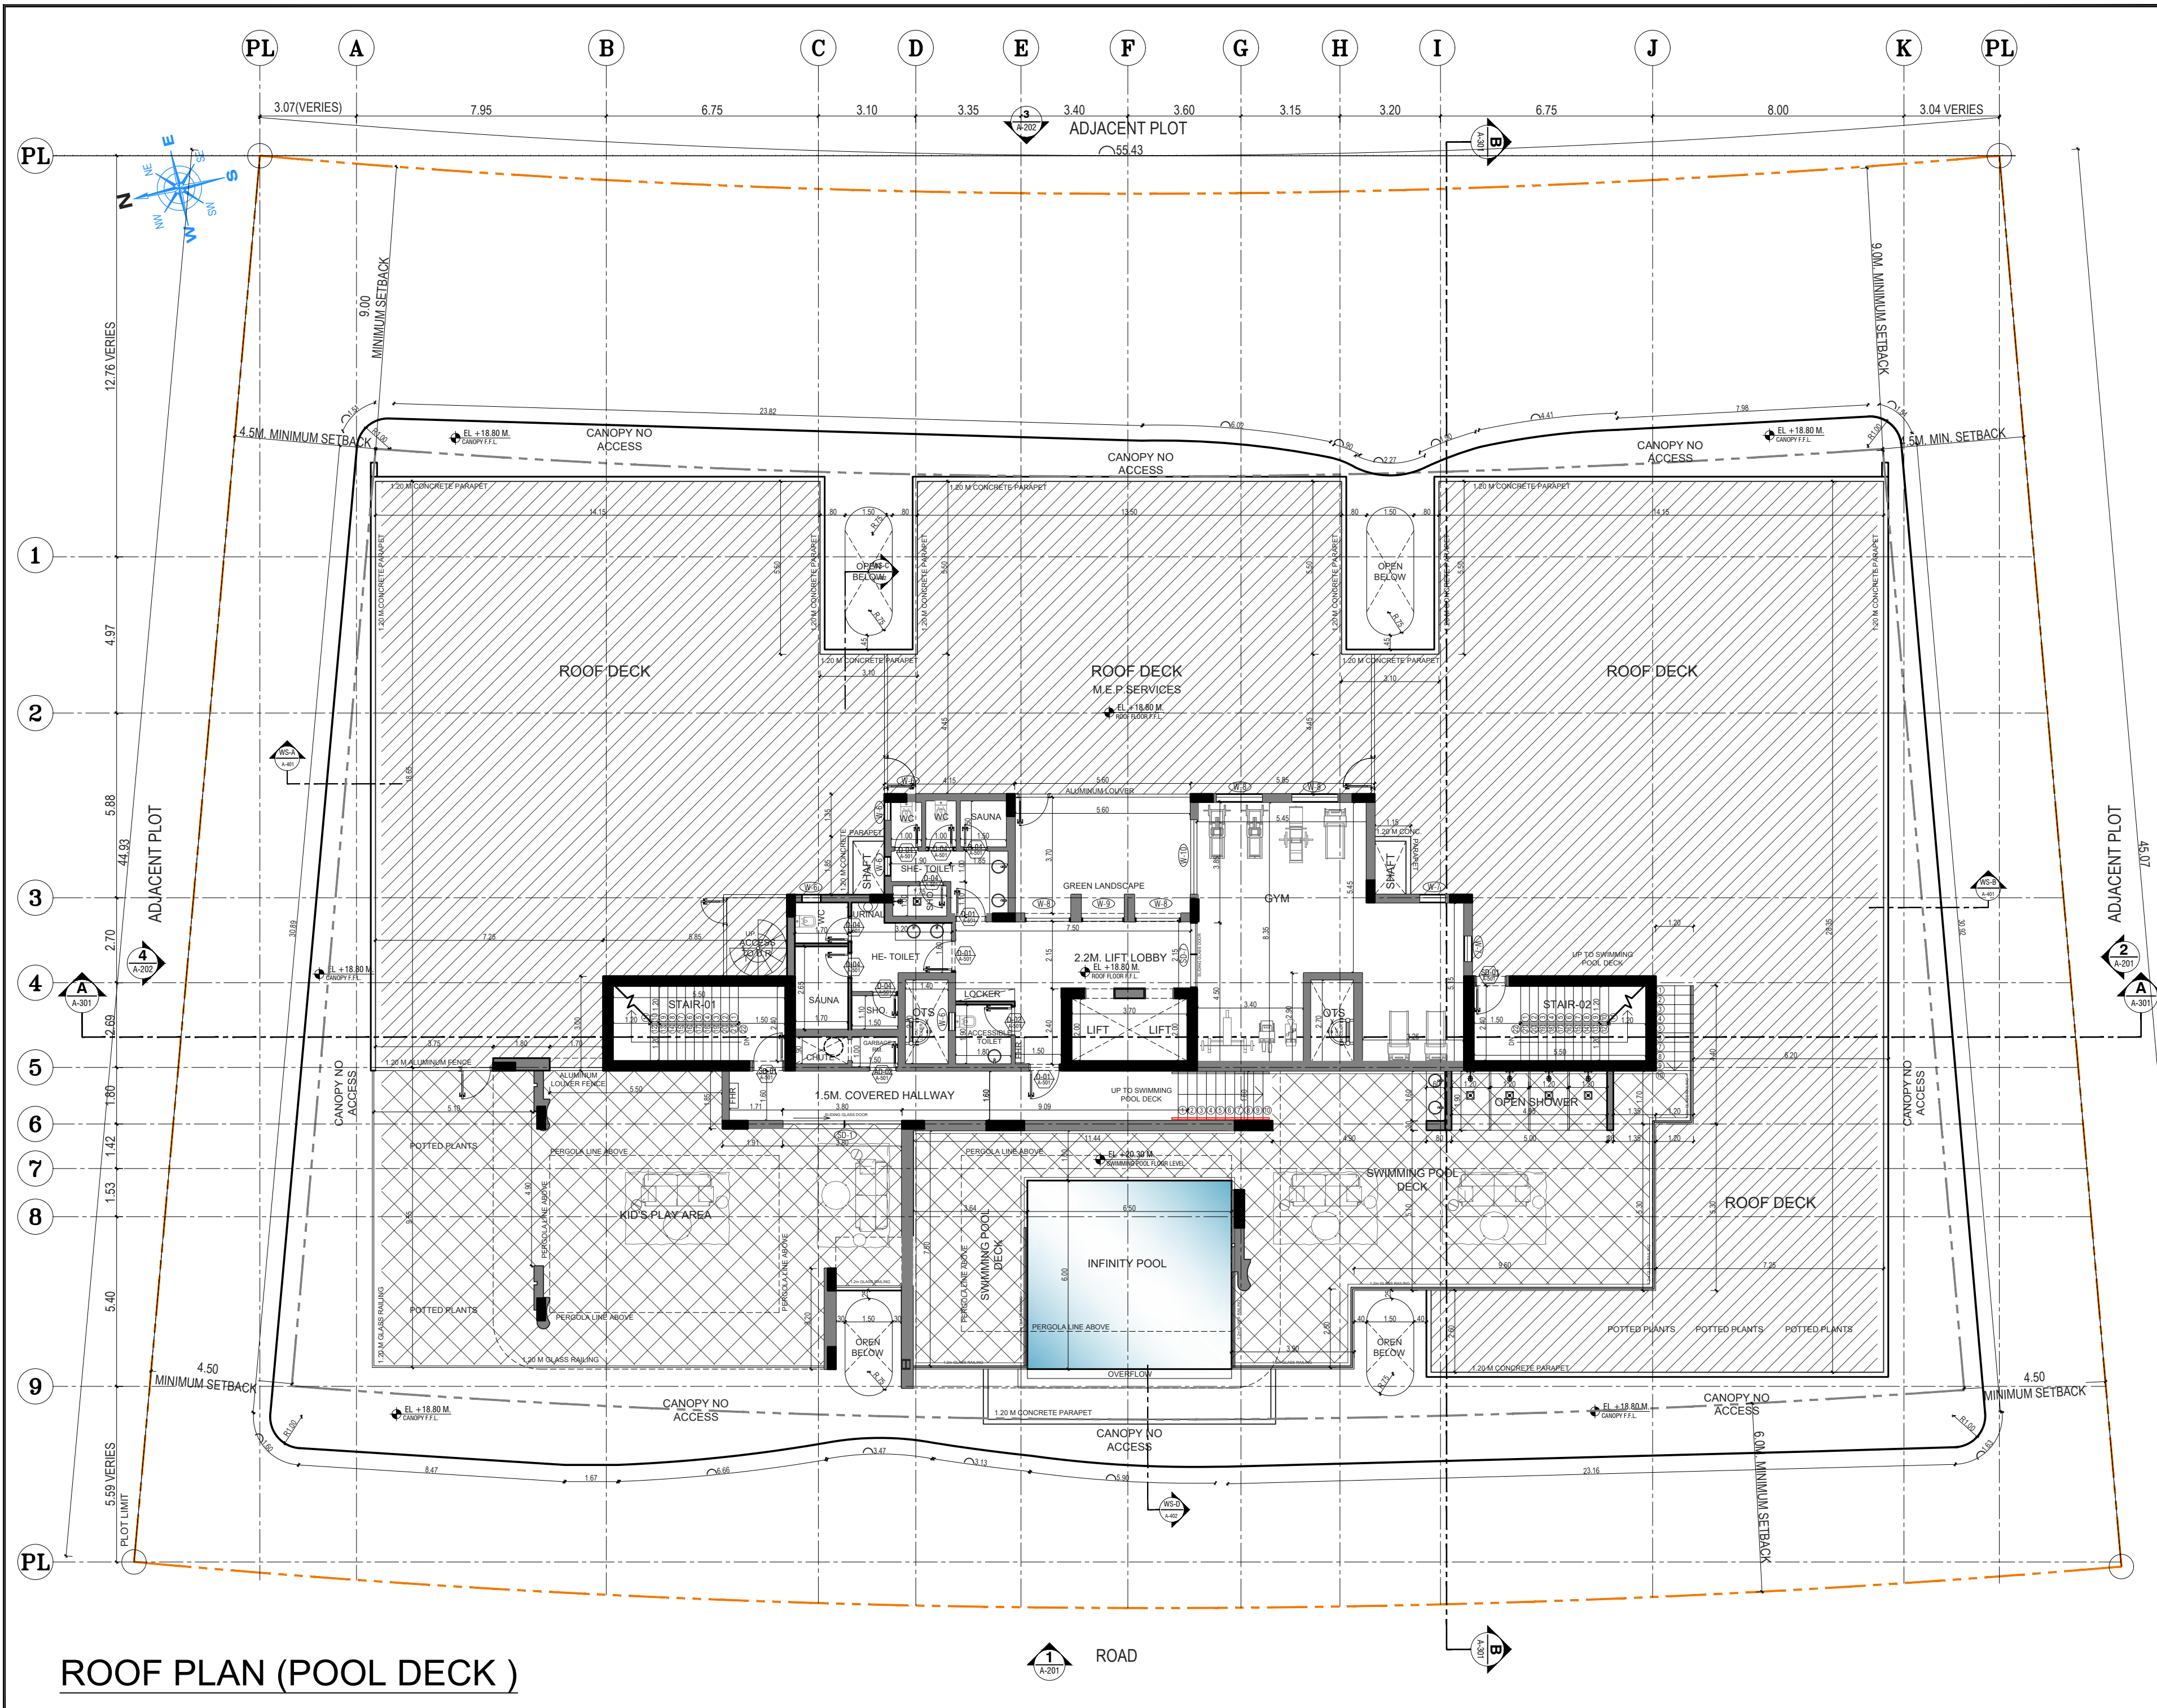

- NOTE:
1. THIS DRAWING IS THE PROPERTY OF MAPLE ENGINEERING CONSULTANTS, P.O. BOX. 214389, DUBAI, U.A.E. IT IS NOT ALLOWED TO REPRODUCE ITS CONTENTS IN ANY FORM EXCEPT FOR THE PURPOSE FOR WHICH IT IS INTENDED.
 2. THIS DRAWING IS NOT TO BE SCALED. STATED DIMENSIONS ONLY ARE TO BE CONSIDERED.
 3. ANY DISCREPANCIES ARE TO BE BROUGHT TO THE ATTENTION OF THE ENGINEER AND RESOLVED BEFORE COMMENCEMENT OF ANY WORK.
 4. FOR CONSTRUCTION S.I. UNIT TO BE FOLLOWED.
 5. THIS DRAWINGS MUST NOT BE USED AS SHOP DRAWINGS / FOR CONSTRUCTION DRAWING. MAIN CONTRACTOR TO PREPARE SHOP DRAWING BASED PROJECT NEEDS, LATEST AUTHORITIES RULES AND REGULATIONS AND PROJECT ACTUAL CONDITION FOR MAPLE AND OWNER'S APPROVAL.
 6. IT IS MAIN CONTRACTOR'S RESPONSIBILITY TO MAKE SHOP DRAWINGS AND FULL COORDINATION WITH ALL SUB-CONTRACTORS IN ORDER TO PREPARE SHOP DRAWINGS.



ARCH. CIVIL. ELEC. TEL. HVAC FIRE F. PLUM. ETC.

REV. NO. DATE DESCRIPTION

CONSULTANT:
MAPLE ENGINEERING CONSULTANTS
TEL: 04-3360663 | FAX: 04-3360667 | P.O. BOX: 214389
WWW.THEMAPLE.AE | EMAIL: info@themaple.ae

CLIENT:
ELTAHIR ELTAYEB YOUNIS

PLOT No.: RG-30 LOCATION: DUBAI AVIATION CITY, DUBAI


PROJECT: P - 345- 2024

PROPOSED G+4+R RESIDENTIAL BUILDING

DRAWING TITLE:

ROOF PLAN (POOL DECK)

DESIGNED BY: MAPLE ENGINEERING CONSULTANTS
ARCHITECT: AR. MARK DESON ABAYON 309120915
ARCHITECT: AR. ELMER ALEA DIAO 113098
STRUCTURAL: ENGR. ASMA AMIRI SHAMLOO 109930
DATE: SEPTEMBER 2, 2025
SCALE: N.T.S. PAPER SIZE: A2
SHEET NO.: A-107 REVISION: 0

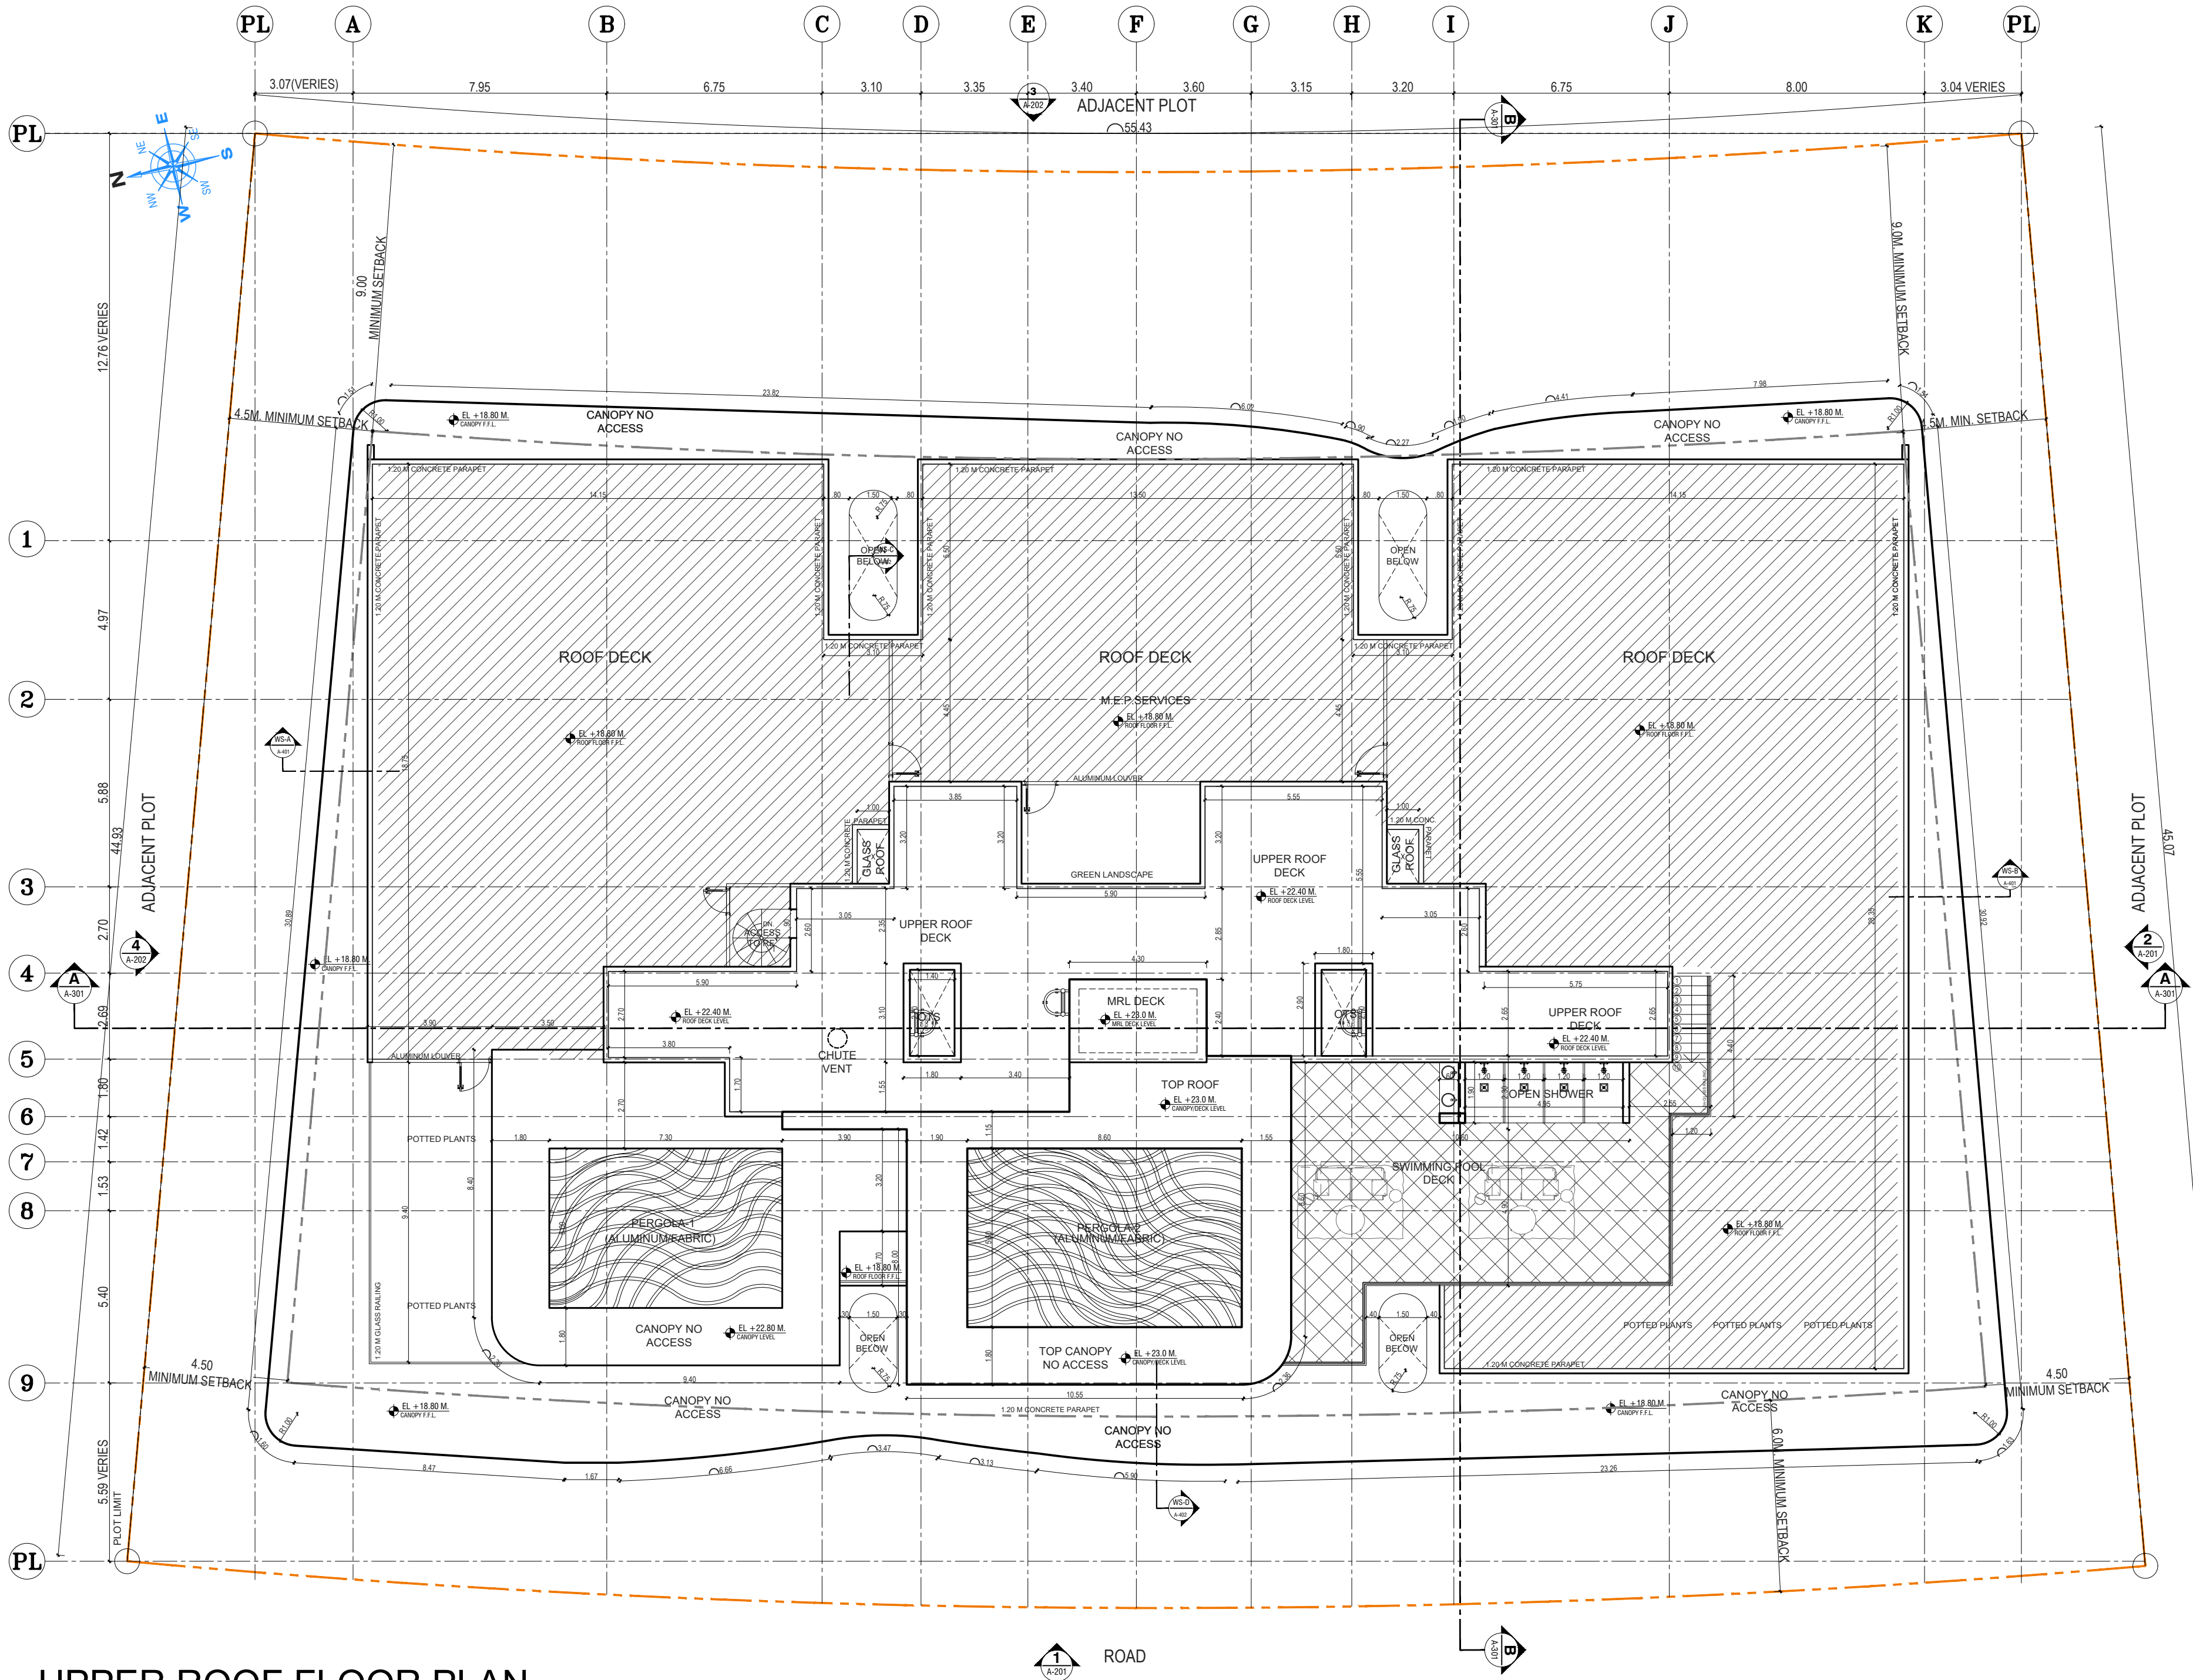

UPPER ROOF FLOOR PLAN

- NOTE:
1. THIS DRAWING IS THE PROPERTY OF MAPLE ENGINEERING CONSULTANTS, P.O. BOX. 214389, DUBAI, U.A.E. IT IS NOT ALLOWED TO REPRODUCE ITS CONTENTS IN ANY FORM EXCEPT FOR THE PURPOSE FOR WHICH IT IS INTENDED.
 2. THIS DRAWING IS NOT TO BE SCALED. STATED DIMENSIONS ONLY ARE TO BE CONSIDERED.
 3. ANY DISCREPANCIES ARE TO BE BROUGHT TO THE ATTENTION OF THE ENGINEER AND RESOLVED BEFORE COMMENCEMENT OF ANY WORK.
 4. FOR CONSTRUCTION S.I. UNIT TO BE FOLLOWED.
 5. THIS DRAWINGS MUST NOT TO BE USED AS SHOP DRAWINGS / FOR CONSTRUCTION DRAWING. MAIN CONTRACTOR TO PREPARE SHOP DRAWING BASED PROJECT NEEDS, LATEST AUTHORITIES RULES AND REGULATIONS AND PROJECT ACTUAL CONDITION FOR MAPLE AND OWNER'S APPROVAL.
 6. IT IS MAIN CONTRACTOR'S RESPONSIBILITY TO MAKE SHOP DRAWINGS AND FULL COORDINATION WITH ALL SUB-CONTRACTORS IN ORDER TO PREPARE SHOP DRAWINGS.



ARCH. CIVIL. ELEC. TEL. HVAC FIRE F. PLUM. ETC.

REV.NO.	DATE	DESCRIPTION

CONSULTANT:

MAPLE ENGINEERING CONSULTANTS

TEL: 04-3360663 | FAX: 04-3360667 | P.O. BOX: 214389
WWW.THEMAPLE.AE | EMAIL: info@themaple.ae

CLIENT: ELTAHIR ELTAYEB YOUNIS

PLOT No.: RG-30 | LOCATION: DUBAI AVIATION CITY, DUBAI

PROJECT: P - 345- 2024

PROPOSED G+4+R RESIDENTIAL BUILDING

DRAWING TITLE:

UPPER ROOF PLAN

DESIGNED BY:	MAPLE ENGINEERING CONSULTANTS
ARCHITECT	AR. MARK DESON ABAYON 309120915
ARCHITECT	AR. ELMER ALEA DIAO 113098
STRUCTURAL	ENGR. ASMA AMIRI SHAMLOO 109930
DATE:	SEPTEMBER 2, 2025
SCALE:	N.T.S. PAPER SIZE: A2
SHEET NO.:	A-108 REVISION: 0